

Copyright Reserved

The Contractor shall verify and be responsible for all dimensions. DO NOT scale the drawing - any errors or omissions shall be reported to Stantec without delay.  
The Copyrights to all designs and drawings are the property of Stantec. Reproduction or use for any purpose other than that authorized by Stantec is forbidden.

Consultants

**Bladykas Engineering, P.C.**

50 Jackson Avenue, Suite 300, Syosset, NY 11791  
tel: 516.364.8700 • fax: 516.364.8707  
web: www.bladykas.com • e-mail: info@bladykas.com


**TDM ENGINEERING**

CONSULTING ENGINEER, P.C.  
550 NORTH COUNTRY ROAD, SUITE F  
SAINT JAMES, NEW YORK 11780  
TEL: (631) 686 - 5234  
FAX: (631) 590 - 1927  
E-MAIL: TDM@TDMENGINEERS.COM

**vhb**

Engineering, Surveying,  
Landscape Architecture  
and Geology, P.C.  
100 Motor Parkway  
Suite 350  
Hauppauge, NY 11788  
631.787.3400

Key Plan

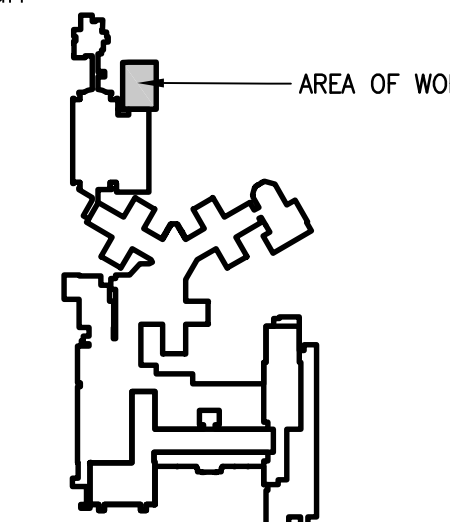

Notes

Revision	By	Appd.	Date
1	30% DASHY COMMENTS RESPONSE	DP	ERC 19.04.02
0	ISSUE FOR SITE PLAN APPROVAL	DP	EC 19.05.06
0	C.O.N. ISSUE	DP	EC 19.01.30

Issued

File Name: 00960\_A-133 - Equipment Plan.dwg  
Dwn. Chkd. Dgn. YF.MM.DD

Permit-Seal


ATTACHMENT "B"

Client/Project  
GOOD SAMARITAN HOSPITAL MEDICAL CENTER  
PEDIATRIC EMERGENCY DEPARTMENT

1000 MONTAUK HIGHWAY  
WEST ISLIP, NEW YORK 11795

Title  
EQUIPMENT PLAN

Project No.	Scale	
191500960-200	AS NOTED	
Drawing No.	Sheet	Revision

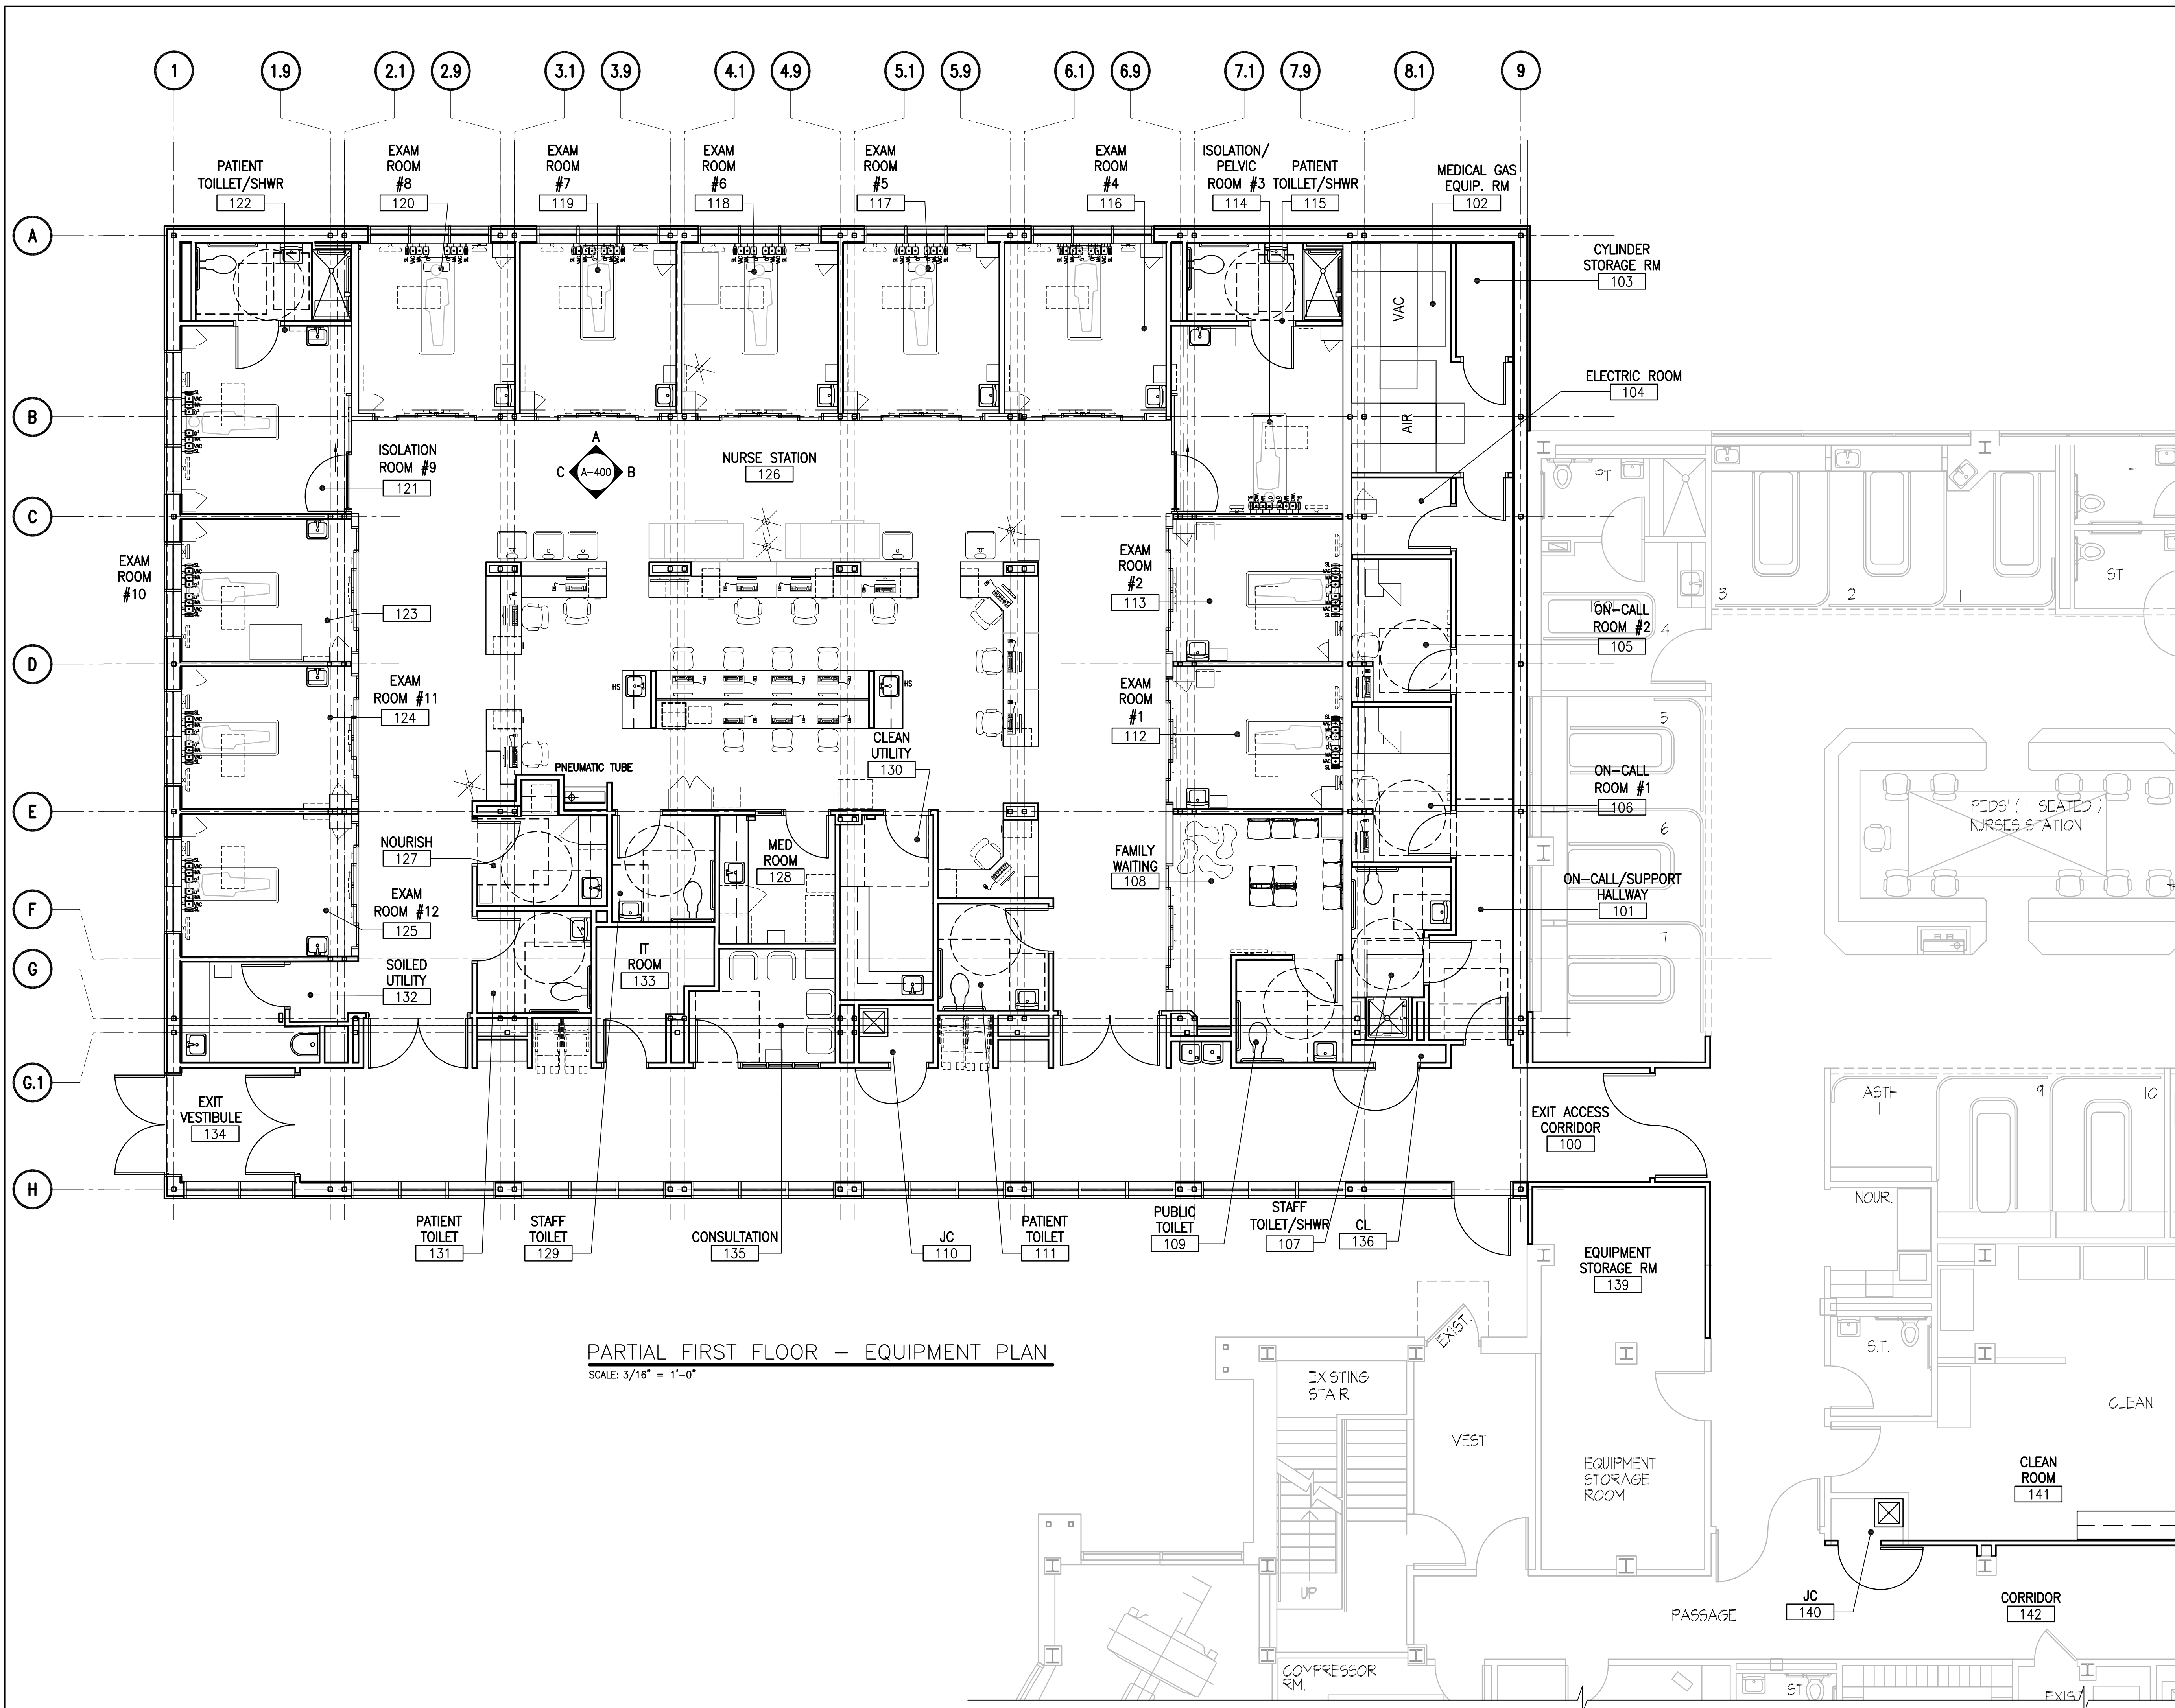

PARTIAL FIRST FLOOR - EQUIPMENT PLAN  
SCALE: 3/16" = 1'-0"

U:\A\191500960\Architecture\Design\Drawing\000\_Pediatric Modular ED\00960\_A-133 - Equipment Plan.dwg  
 2019/05/03 12:14 PM By: Paul Deanna